




2 FIRE DETECTION ALARM SYSTEM RISER DIAGRAM
ECE-1 SCALE NTS

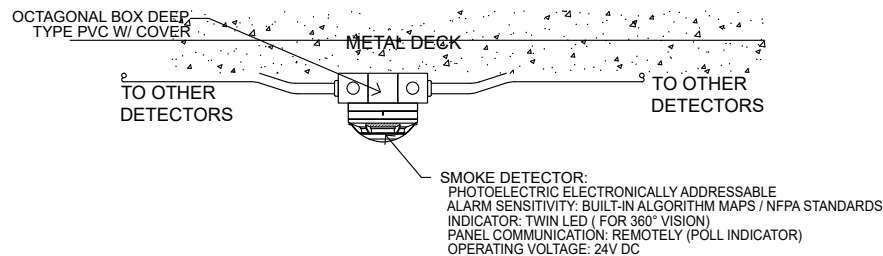

3 MOUNTING DETAIL ADDRESSABLE SMOKE/HEAT DETECTOR
ECE-1 SCALE NTS

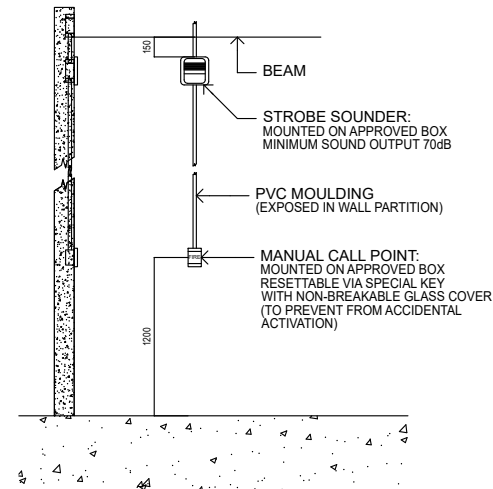

4 MOUNTING DETAIL MANUAL PULL SWITCH WITH ALARM BELL
ECE-1 SCALE NTS

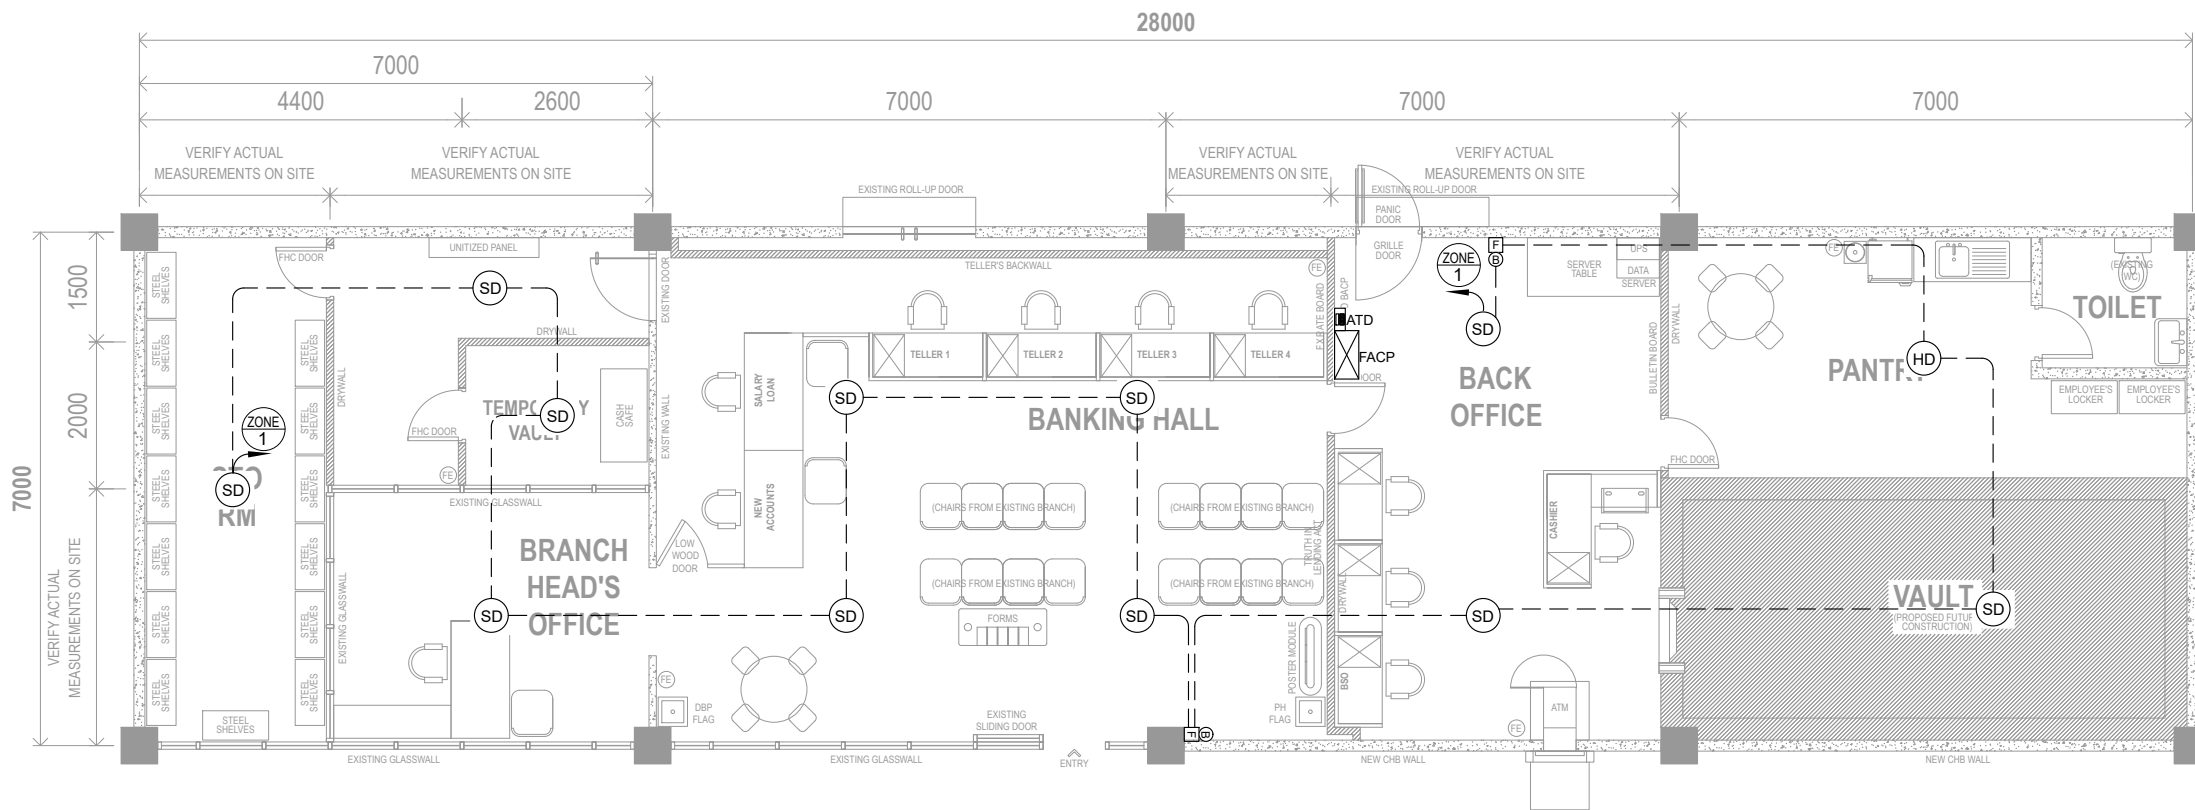

1 FIRE DETECTION ALARM SYSTEM LAYOUT
ECE-1 SCALE 1:100 MTS

LEGEND:

	FIRE ALARM CONTROL PANEL
	AUTOMATIC TELEPHONE DIALER (INSTALLED ON WALLS 140CM FROM FINISHED FLOOR LINE)
	SMOKE DETECTOR
	HEAT DETECTOR
	MANUAL CALL POINT WITH STROBE SOUNDER
	CIRCUIT HOMERUN NUMBER INDICATES ZONING
	CIRCUIT CONNECTION

NOTES:
1.) PROVIDE 1.5M ALLOWANCE FOR ADDITIONAL/ RELOCATION FIRE DETECTION ALARM DEVICES BASED ON ACTUAL BFP INSPECTION.
2.) SUBMIT ALL SAMPLES FOR APPROVAL OF DBP. NO PURCHASE & INSTALLATION TO BE DONE W/O DBP'S APPROVAL.
3.) WRITTEN DIMENSIONS ON THESE DRAWINGS SHALL HAVE PRECEDENCE OVER SCALED DIMENSIONS.
4.) CONTRACTOR SHALL VERIFY AND BE RESPONSIBLE FOR ALL DIMENSIONS AND CONDITIONS ON THE JOB.
5.) DISCREPANCIES BETWEEN DRAWINGS AND ACTUAL CONDITION MUST BE IMMEDIATELY FORWARDED TO CFMD FOR RESOLUTION.

PROJECT TITLE:
SUPPLY, DELIVERY, INSTALLATION AND TESTING & COMMISSIONING OF FIRE DETECTION ALARM SYSTEM (FDAS) FOR DBP IRIGA BRANCH
LOCATION: ICT BUILDING, POBLACION ROAD, STA. CRUZ SUR, IRIGA CITY

OWNER:
DEVELOPMENT BANK OF THE PHILIPPINES
AUTHORIZED REPRESENTATIVE

SHEET CONTENT:
FIRE ALARM SYSTEM LAYOUT
FIRE ALARM SYSTEM RISER DIAGRAM
MANUAL CALL POINT WITH STROBE SOUNDER MOUNTING DETAILS
ADDRESSABLE SMOKE DETECTOR MOUNTING DETAILS

ISSUE DATE : MAY 2025
REV. DATE:
REVIEWED BY:

SHEET NO:
ECE
1