



- NOTE:
1. PROVIDE 1.5M ALLOWANCE FOR ADDITIONAL/ RELOCATION OF FIRE DETECTION ALARM DEVICES DURING INSPECTION TURN-OVER.
 2. SUBMIT ALL SAMPLES FOR APPROVAL OF DBP. NO PURCHASE & INSTALLATION TO BE DONE W/O DBP'S APPROVAL.
 3. WRITTEN DIMENSIONS ON THESE DRAWINGS SHALL HAVE PRECEDENCE OVER SCALED DIMENSIONS.
 4. CONTRACTOR SHALL VERIFY AND BE RESPONSIBLE FOR ALL DIMENSIONS AND CONDITIONS ON THE JOB.
 5. DISCREPANCIES IN MEASUREMENTS (AND SPECIFICATIONS) BETWEEN DRAWINGS AND ACTUAL CONDITION MUST BE IMMEDIATELY FORWARDED TO CFMD FOR RESOLUTION.

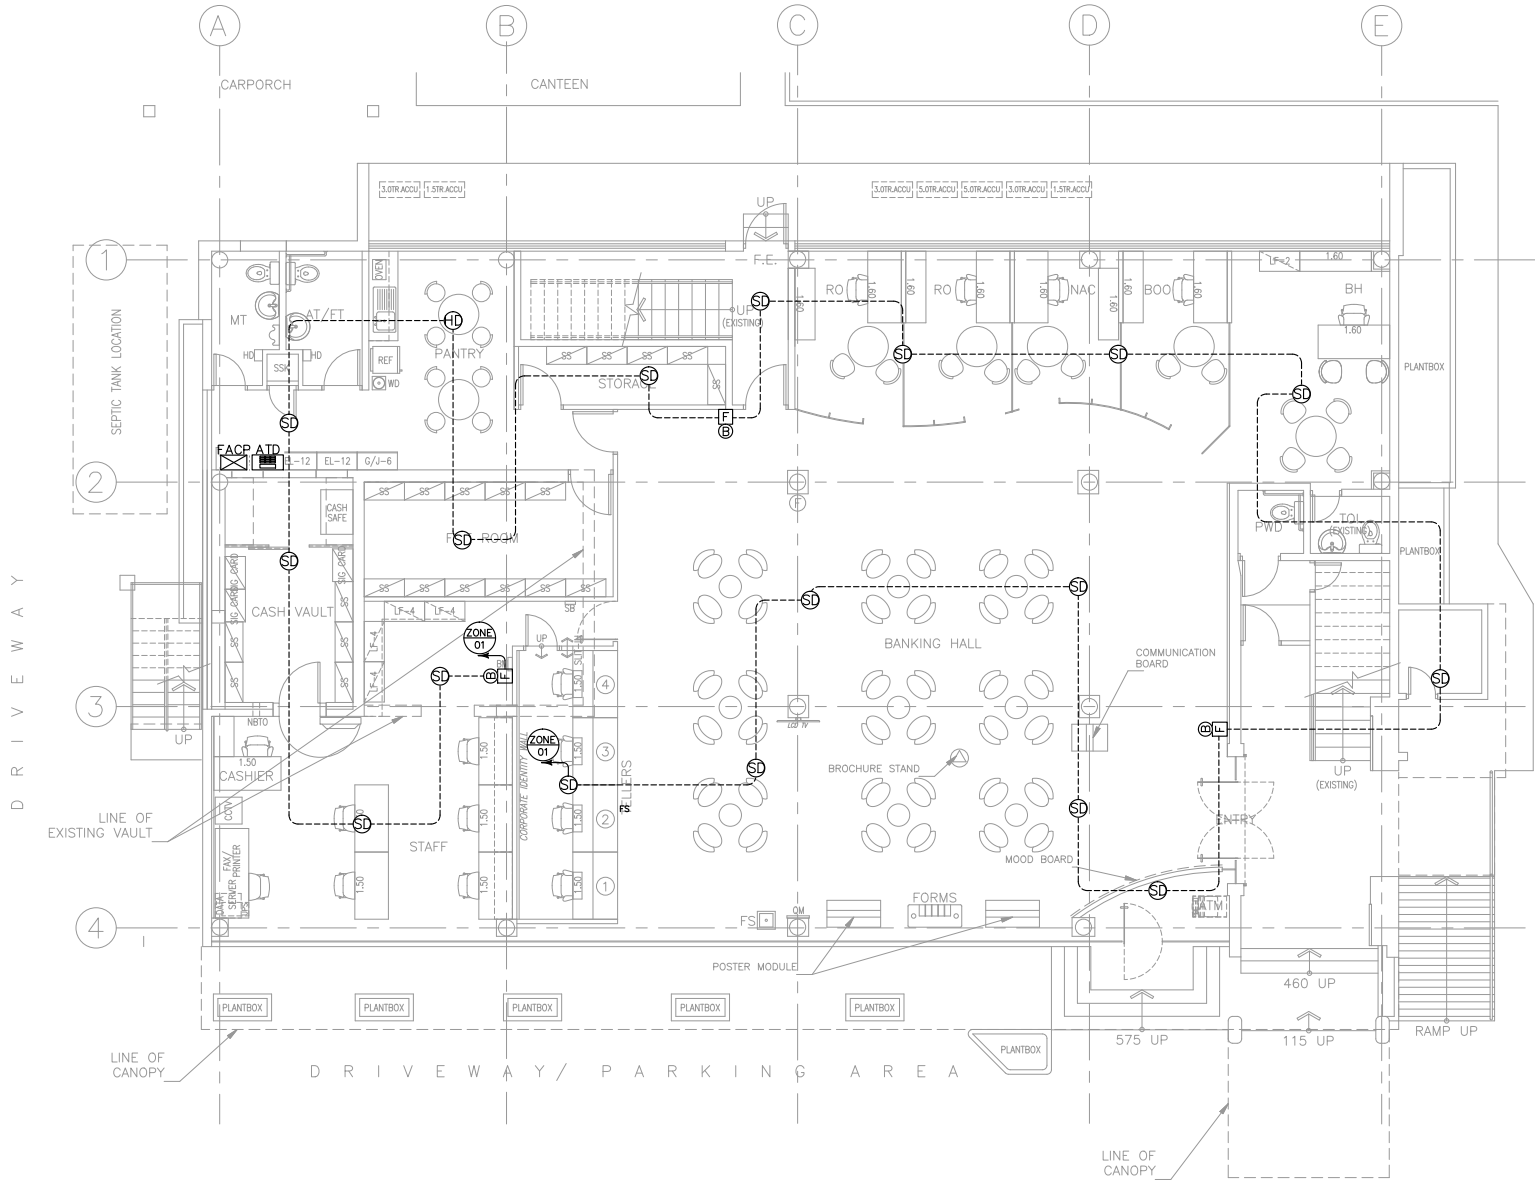


1
ECE-1 **SCALE** **1:100** **METERS**
FIRE ALARM SYSTEM LAYOUT

LEGEND:


	FIRE ALARM CONTROL PANEL		SMOKE DETECTOR / HEAT DETECTOR		CIRCUIT RUN CONCEALED INSIDE PARTITION OR CEILING VOID
	AUTOMATIC TELEPHONE DIALER (INSTALLED ON WALLS 140CM FROM FINISHED FLOOR LABEL)		MANUAL CALL POINT WITH STROBE SOUNDER		CIRCUIT HOMERUN NUMBER INDICATES ZONING

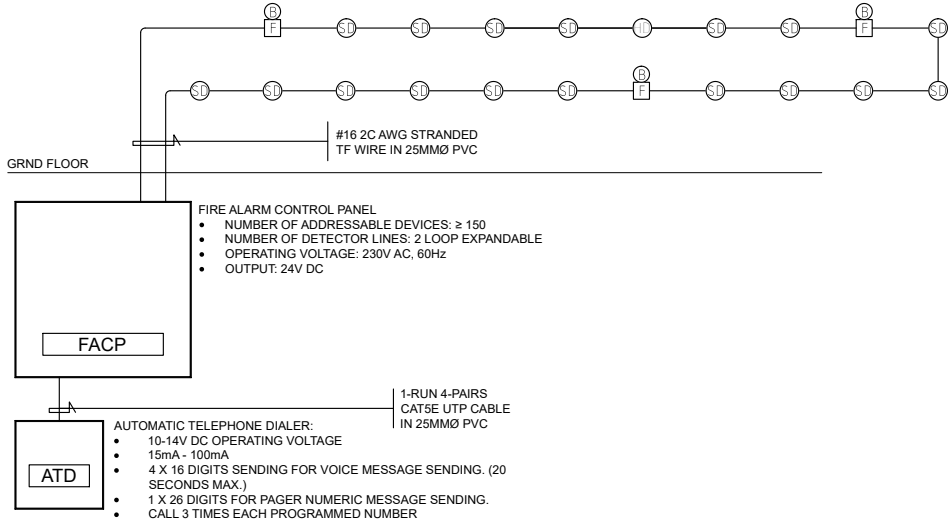

2
ECE-1 **NOT TO SCALE**
**RISER DIAGRAM
FIRE DETECTION ALARM SYSTEM**

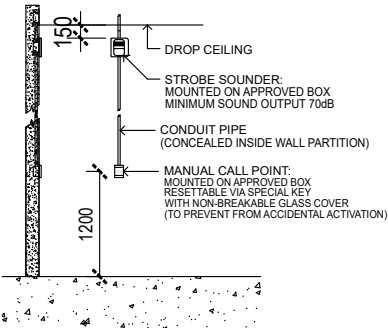

3
ECE-1 **NOT TO SCALE**
**MOUNTING DETAILS
ADDRESSABLE MANUAL CALL POINT WITH STROBE SOUNDER**

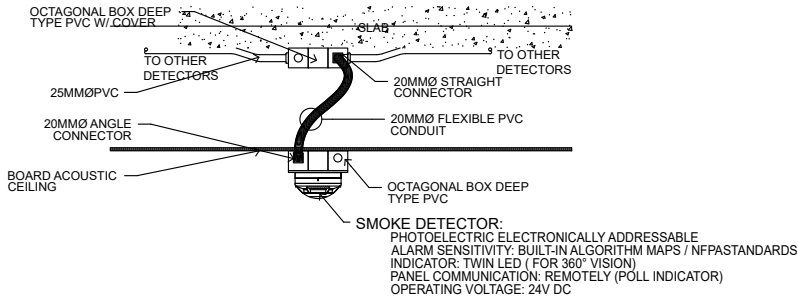

4
ECE-1 **NOT TO SCALE**
**MOUNTING DETAILS
ADDRESSABLE SMOKE DETECTOR**

	PROJECT TITLE:			OWNER:	SHEET CONTENT:	ISSUE DATE : MAY 2025	SHEET NO:
	SUPPLY, DELIVERY, INSTALLATION AND TESTING & COMMISSIONING OF FIRE DETECTION ALARM SYSTEM (FDAS) FOR DBP LEGAZPI BRANCH		REG. NO.	DEVELOPMENT BANK OF THE PHILIPPINES	FIRE ALARM SYSTEM LAYOUT FIRE ALARM SYSTEM RISER DIAGRAM MANUAL CALL POINT WITH STROBE SOUNDER MOUNTING DETAILS ADDRESSABLE SMOKE DETECTOR MOUNTING DETAILS	REV. DATE:	ECE 1
	LOCATION: DBP BUILDING QUEZON AVE., LEGAZPI CITY, ALBAY		ISSUED ON	AUTHORIZED REPRESENTATIVE		REVIEWED BY:	
			TIN NO.				