


**NOTE:**


1. PROVIDE 1.5M ALLOWANCE FOR ADDITIONAL/ RELOCATION OF FIRE DETECTION ALARM DEVICES DURING INSPECTION TURN-OVER.
2. SUBMIT ALL SAMPLES FOR APPROVAL OF DBP. NO PURCHASE & INSTALLATION TO BE DONE W/O DBP'S APPROVAL.
3. WRITTEN DIMENSIONS ON THESE DRAWINGS SHALL HAVE PRECEDENCE OVER SCALED DIMENSIONS.
4. CONTRACTOR SHALL VERIFY AND BE RESPONSIBLE FOR ALL DIMENSIONS AND CONDITIONS ON THE JOB.
5. DISCREPANCIES IN MEASUREMENTS (AND SPECIFICATIONS) BETWEEN DRAWINGS AND ACTUAL CONDITION MUST BE IMMEDIATELY FORWARDED TO GMD FOR RESOLUTION.

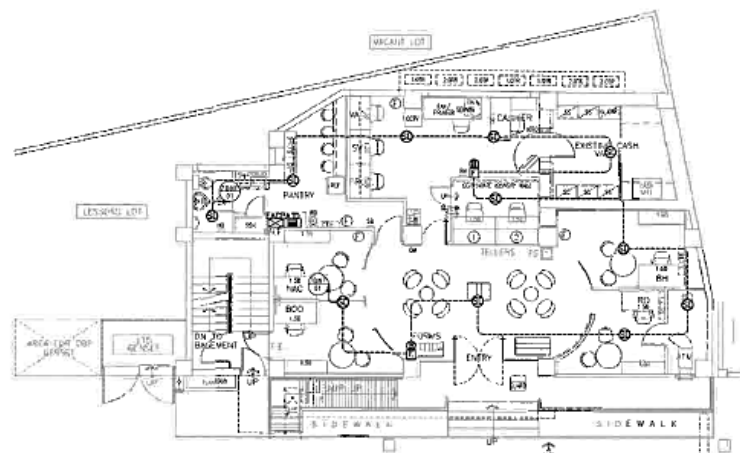


**1 FIRE ALARM SYSTEM LAYOUT**  
ECE-1 SCALE 1:100 METERS

**LEGEND:**


	FIRE ALARM CONTROL PANEL		SMOKE DETECTOR/HEAT DETECTOR		CROSSLINK CONCEALED INSIDE PARTITION OR CEILING VOID
	AUTOMATIC TELEPHONE DIALER (INSTALLED ON WALLS 1400MM FROM FINISHED FLOOR LEVEL)		MANUAL CALL POINT WITH STROBE SOUNDER		CROSSLINK NUMBER INDICATES ZONING

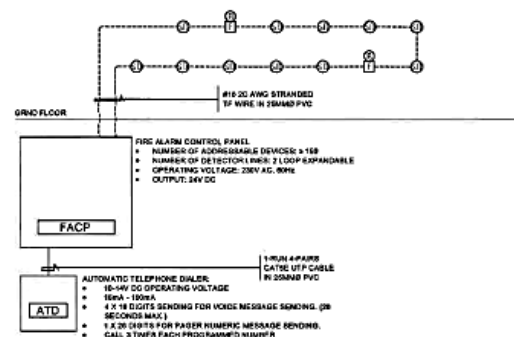

**2 RISER DIAGRAM**  
ECE-1 NOT TO SCALE

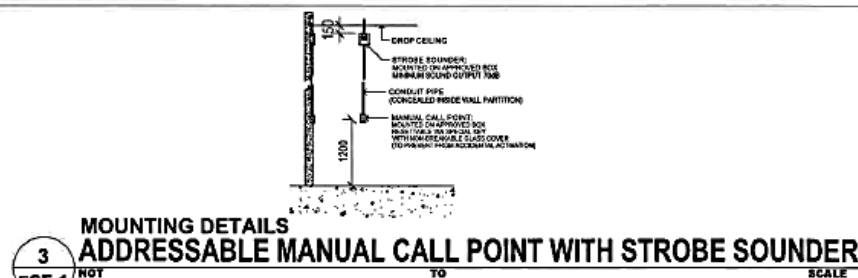

**3 ADDRESSABLE MANUAL CALL POINT WITH STROBE SOUNDER**  
ECE-1 NOT TO SCALE

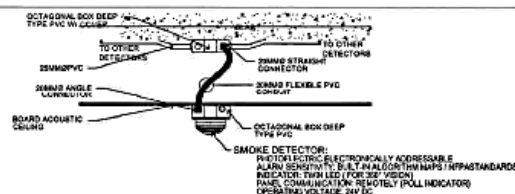

**4 MOUNTING DETAILS**  
ECE-1 NOT TO SCALE



**PROJECT TITLE:**  
SUPPLY, DELIVERY, INSTALLATION AND TESTING & COMMISSIONING OF FIRE DETECTION ALARM SYSTEM (FDAS) FOR DBP BASILAN BRANCH

**LOCATION:** AC INFANTE INCORPORATED BUILDING, A.C. ALANO ST., BABELA CITY, BASILAN

**ENDORSED BY:**  
SIGNED  
ENGR. BRYAN MARROJO T. PRINCIPLE  
TECHNICAL STAFF, TCMU-GMD

**DESIGNED BY:**  
SIGNED  
SM EDWIN C. PICON  
THE HEAD, TCMU-GMD

**ENDORSED FOR APPROVAL BY:**  
SIGNED  
ENGR. MICHAEL ANTONIO F. CANGIO  
THE HEAD, TCMU-GMD

**APPROVED BY:**  
SIGNED  
SM ALBERTO SANTANILLA, BERNEJO  
COORDINATOR, TCMU-GMD

**SHEET CONTENT:**  
FIRE ALARM SYSTEM LAYOUT  
FIRE ALARM SYSTEM RISER DIAGRAM  
MANUAL CALL POINT WITH STROBE SOUNDER MOUNTING DETAILS  
ADDRESSABLE SMOKE DETECTOR MOUNTING DETAILS

**ISSUE DATE:** MAY 2025  
**REV. DATE:**  
**REVIEWED BY:**  
**SHEET NO.:** ECE-1  
**ECE-1 of 1**